

GENERAL REFLECTED CEILING PLAN NOTES

- A) ALL CEILING HEIGHTS INDICATED ON PLANS ARE FROM TOP OF FINISH FLOOR TO UNDERSIDE OF FINISH CEILING U.N.O.
- B) PROVIDE ADEQUATE CLEARANCES FOR DUCTS AND RELATED APPURTENANT ITEMS NECESSARY TO MAINTAIN THE SPECIFIED CEILING HEIGHT ABOVE THE FINISH FLOOR FOR LIGHT FIXTURES.
- C) SEE ELECTRICAL DRAWINGS FOR FIXTURE MODEL NUMBER AND QUANTITIES.
- D) PROVIDE HANGER AND SAFETY WIRE FOR LIGHT FIXTURES, SPEAKERS AND AIR SUPPLY/RETURN DIFFUSERS (AS REQUIRED)
- E) SEE MECHANICAL DRAWINGS FOR DIFFUSER LOCATIONS. ARCHITECTURAL DRAWINGS DETERMINE LUMINAIRE LOCATION AND OTHER ARCHITECTURAL ITEMS AND SUPERCEDE ALL OTHER CEILING APPURTENANCES.
- F) PREP AND PAINT EXPOSED CEILING, DECK, DUCTS, PIPING, ETC., (PER MANUFACTURERS SPECIFICATIONS)
- G) IT IS THE CONTRACTORS RESPONSIBILITY TO AIM SPOT LIGHTS PER OWNERS DIRECTION. (APPROXIMATE HEIGHT FOR HOT SPOT AT 72")
- H) ALL ELEMENTS SUSPENDED FROM THE DECK THAT OVERHANGS A PEDESTRIAN WAY SHALL BE A MINIMUM OF 80" ABOVE THE WALKING SURFACE AS MEASURED FROM THE BOTTOM OF THE OBSTRUCTION PER 2016 C.B.C. SECTION 11B-307.4

REFLECTED CEILING NOTES

KEYNOTES


- 1 RELOCATED HVAC DIFFUSER
- 2 RELOCATED LIGHT FIXTURE
- 3 EXTEND EXISTING SOFFIT
- 4 NEW LIGHT FIXTURES ON (E) CIRCUIT
- 5 RE-USE (E) FIXTURES IN NEW SUSP. CLG.

KEYNOTES

CEILING LEGEND

- NEW 2X4 SUSPENDED ACOUSTIC CEILING GRIDS W/ NEW TILES
- EXIST. 2X4 SUSPENDED ACOUSTIC CEILING GRIDS W/ EXIST. TILES
- NEW GYP. BD. CEILING
- EXISTING GYP. BD. CEILING
- ELECT. FIXTURES PER ELECT. PLAN

CEILING LEGEND

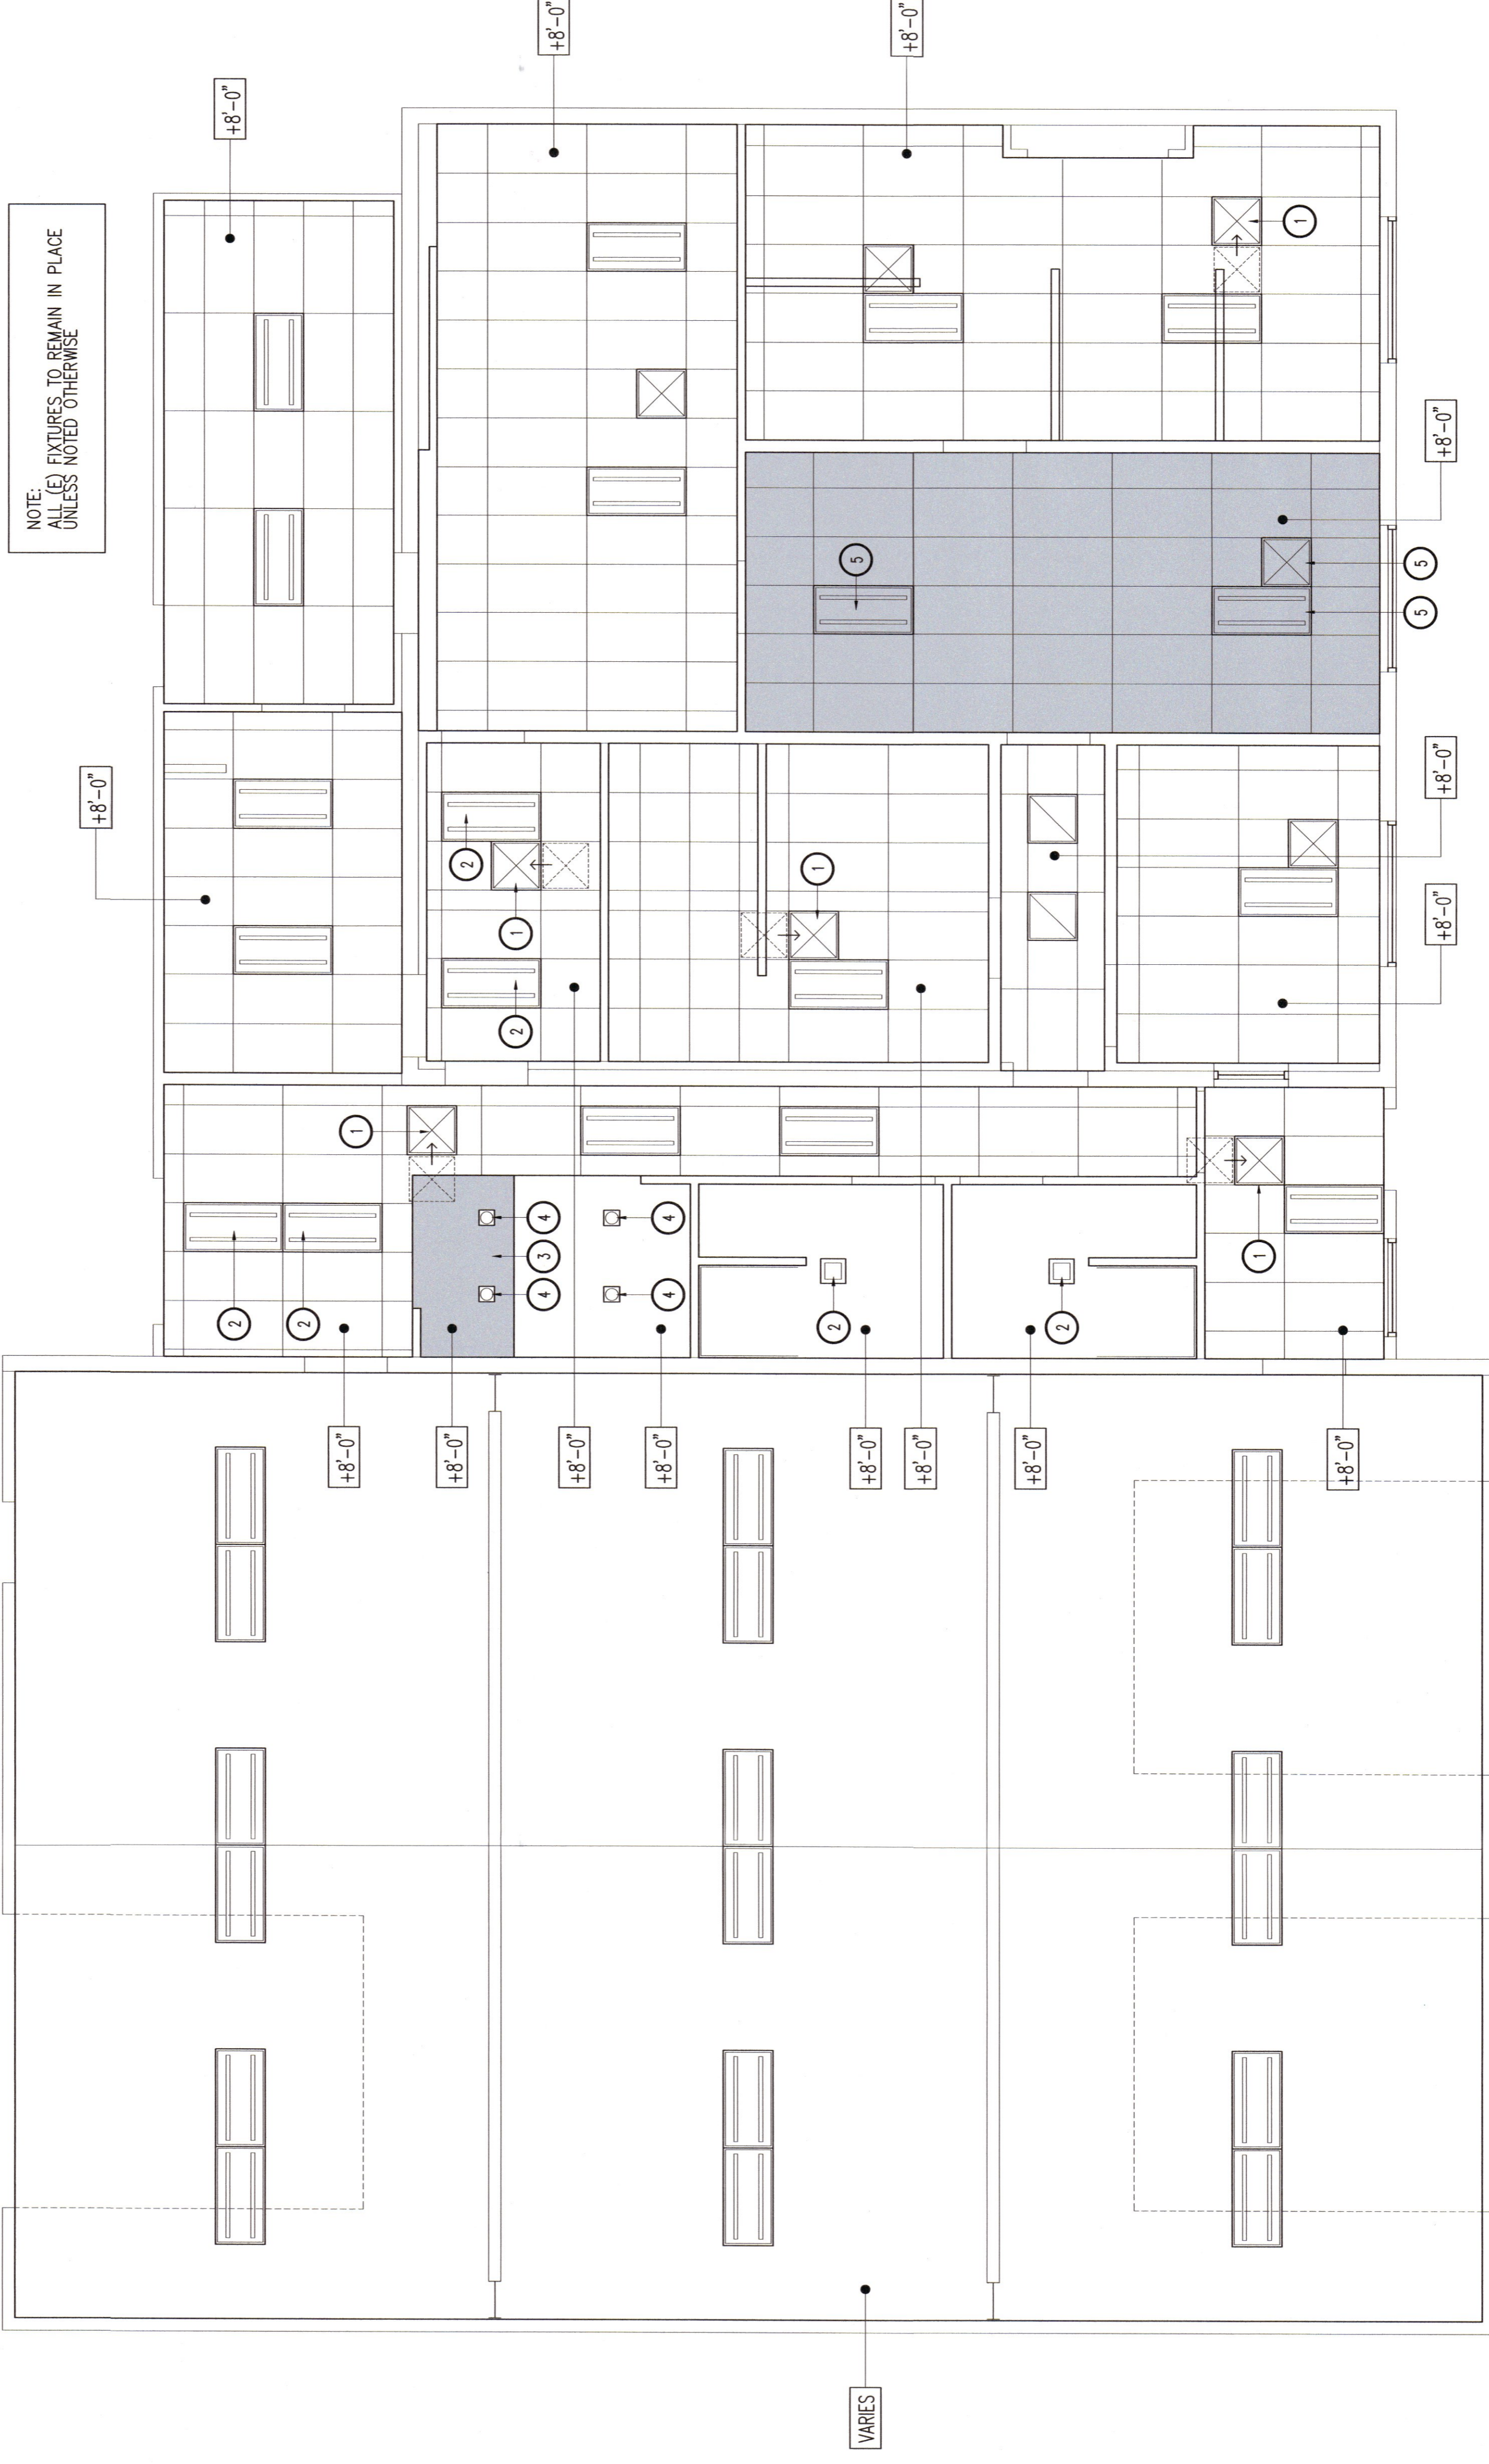

RECEIVED  
MAY 04 2021  
EL DORADO COUNTY  
BUILDING DIVISION

APPROVED FOR PERMITS  
DATE: 07/28/2020  
BY: [Signature]

ARCHITECT'S STAMP



CONSULTANT

PROJECT NAME

COUNTY  
FIRE STATION NO. 17  
REMODEL

PROJECT ADDRESS

6476  
6450 PONY EXPRESS TRAIL  
POLLOCK PINES, CA 95726

DRAWING NAME

REFLECTED  
CEILING PLAN

SUBMITTAL

DATE

NO DATE REVISION

NO DATE REVISION

NO DATE REVISION

NO DATE REVISION

NO DATE REVISION

NO DATE REVISION

DRAWN BY: JK

CHECKED BY: JK

DATE: 07/28/2020

SCALE: NOTED

PROJECT NUMBER: 202103

DRAWING NUMBER: