

ARCHITECT'S STAMP

CONSULTANT

PROJECT NAME  
**COUNTY  
 FIRE STATION NO. 17  
 REMODEL**

PROJECT ADDRESS  
 6430 PONY EXPRESS TRAIL  
 POLLOCK PINES, CA 95726

DRAWING NAME  
**REFLECTED  
 CEILING PLAN**

SUBMITTAL DATE

NO	DATE	REVISION
△		
△		
△		
△		
△		

DRAWN BY: JK  
 CHECKED BY: JK  
 DATE: 07/28/2020  
 SCALE: NOTED  
 PROJECT NUMBER: 202103  
 DRAWING NUMBER:

EP1

**Electrical Schedule:**

ELECTRICAL NOTE:  
 1. ALL WIRING SHALL BE ROMEX APPROPRIATELY SIZED FOR THE CIRCUITS. ANY NON-ROMEX WIRING SHALL BE REMOVED & REPLACED WITH ROMEX.

- LED STRIP LIGHTING
- LIGHTING FIXTURE
- SURFACED MTD LTG FIXTURE
- RECESSED LTG FIXTURE
- EXTERIOR FLOOD LTG W/ MOTION SENSOR
- EXHAUST FAN-LIGHT COMBO
- CARBON MONOXIDE DETECTOR
- SMOKE DETECTOR HARD WIRED & BATTERY BACK UP.
- 110V 110V DUPLEX RECEPTACLE
- 110V DUPLEX ARC FAULT PROTECTED REC.
- 220V RECEPTACLE
- COMMUNICATIONS
- TELEPHONE
- LIGHT SWITCH
- O: OCCUPANCY SENSOR
- D: DIMMER
- H: HUMIDISTAT CONTROLLED
- 220V receptical
- SPEAKER
- GARBAGE DISPOSAL
- UNDER CABINET
- SPEAKER VOLUME
- LUMINATED EXIT LIGHTING

--- ROMEX CIRCUITRY WIRING

**PLUMBING SCHEDULE**


- NOTE: ABOVE CEILING WATER PIPING SHALL BE PEX CONVERTING TO COPPER AT WALLS.
- CW COLD WATER LINE-SIZE PER PLAN
  - HW HOT WATER LINE-SIZE PER PLAN
  - FAC WATER & LPG LINES FROM ABOVE CEILING
  - VTR VENT THROUGH ROOF-SIZE PER PLAN
  - C/O CLEAN OUT-SIZE PER PLAN
  - W WASTE LINE
  - T HOSE BIB
  - 1/2" PVC AIR LINE
  - LPG LINE PER PLAN

GENERAL NOTES:  
 1. SEE SHT 6 FOR PLUMBING DESIGN OF KITCHEN, BATHROOMS & LAUNDRY RM.

MECHANICAL NOTE:  
 1. APPROVED FIRE DAMPERS SHALL BE INSTALLED WHERE ANY HVAC DUCTING PENETRATES A THR FIRE WALL ASSEMBLY (BUNK ROOM). SEE SHT 7 FOR FIRE DAMPER ASSEMBLY DETAILS.

APPROVED plans  
 & Errors at callers  
 Consideration to be completed with  
 MAY 13, 2021  
 215613

ELECTRICAL DESIGN & INSTALLATION	PLUMBING DESIGN & INSTALLATION
PLEASANT VALLEY POWER & LTG. 5280 TWIN CEDARS RD. PLACERVILLE, CA 95667 RALPH TEEVAN: 530-919-1038	BERGSMAN PLUMBING 5838 MOTHERLODE DR STE E PLACERVILLE, CA 95667 STEVE BERGSMAN
CCL#:	CCL#:
SIGNATURE	SIGNATURE

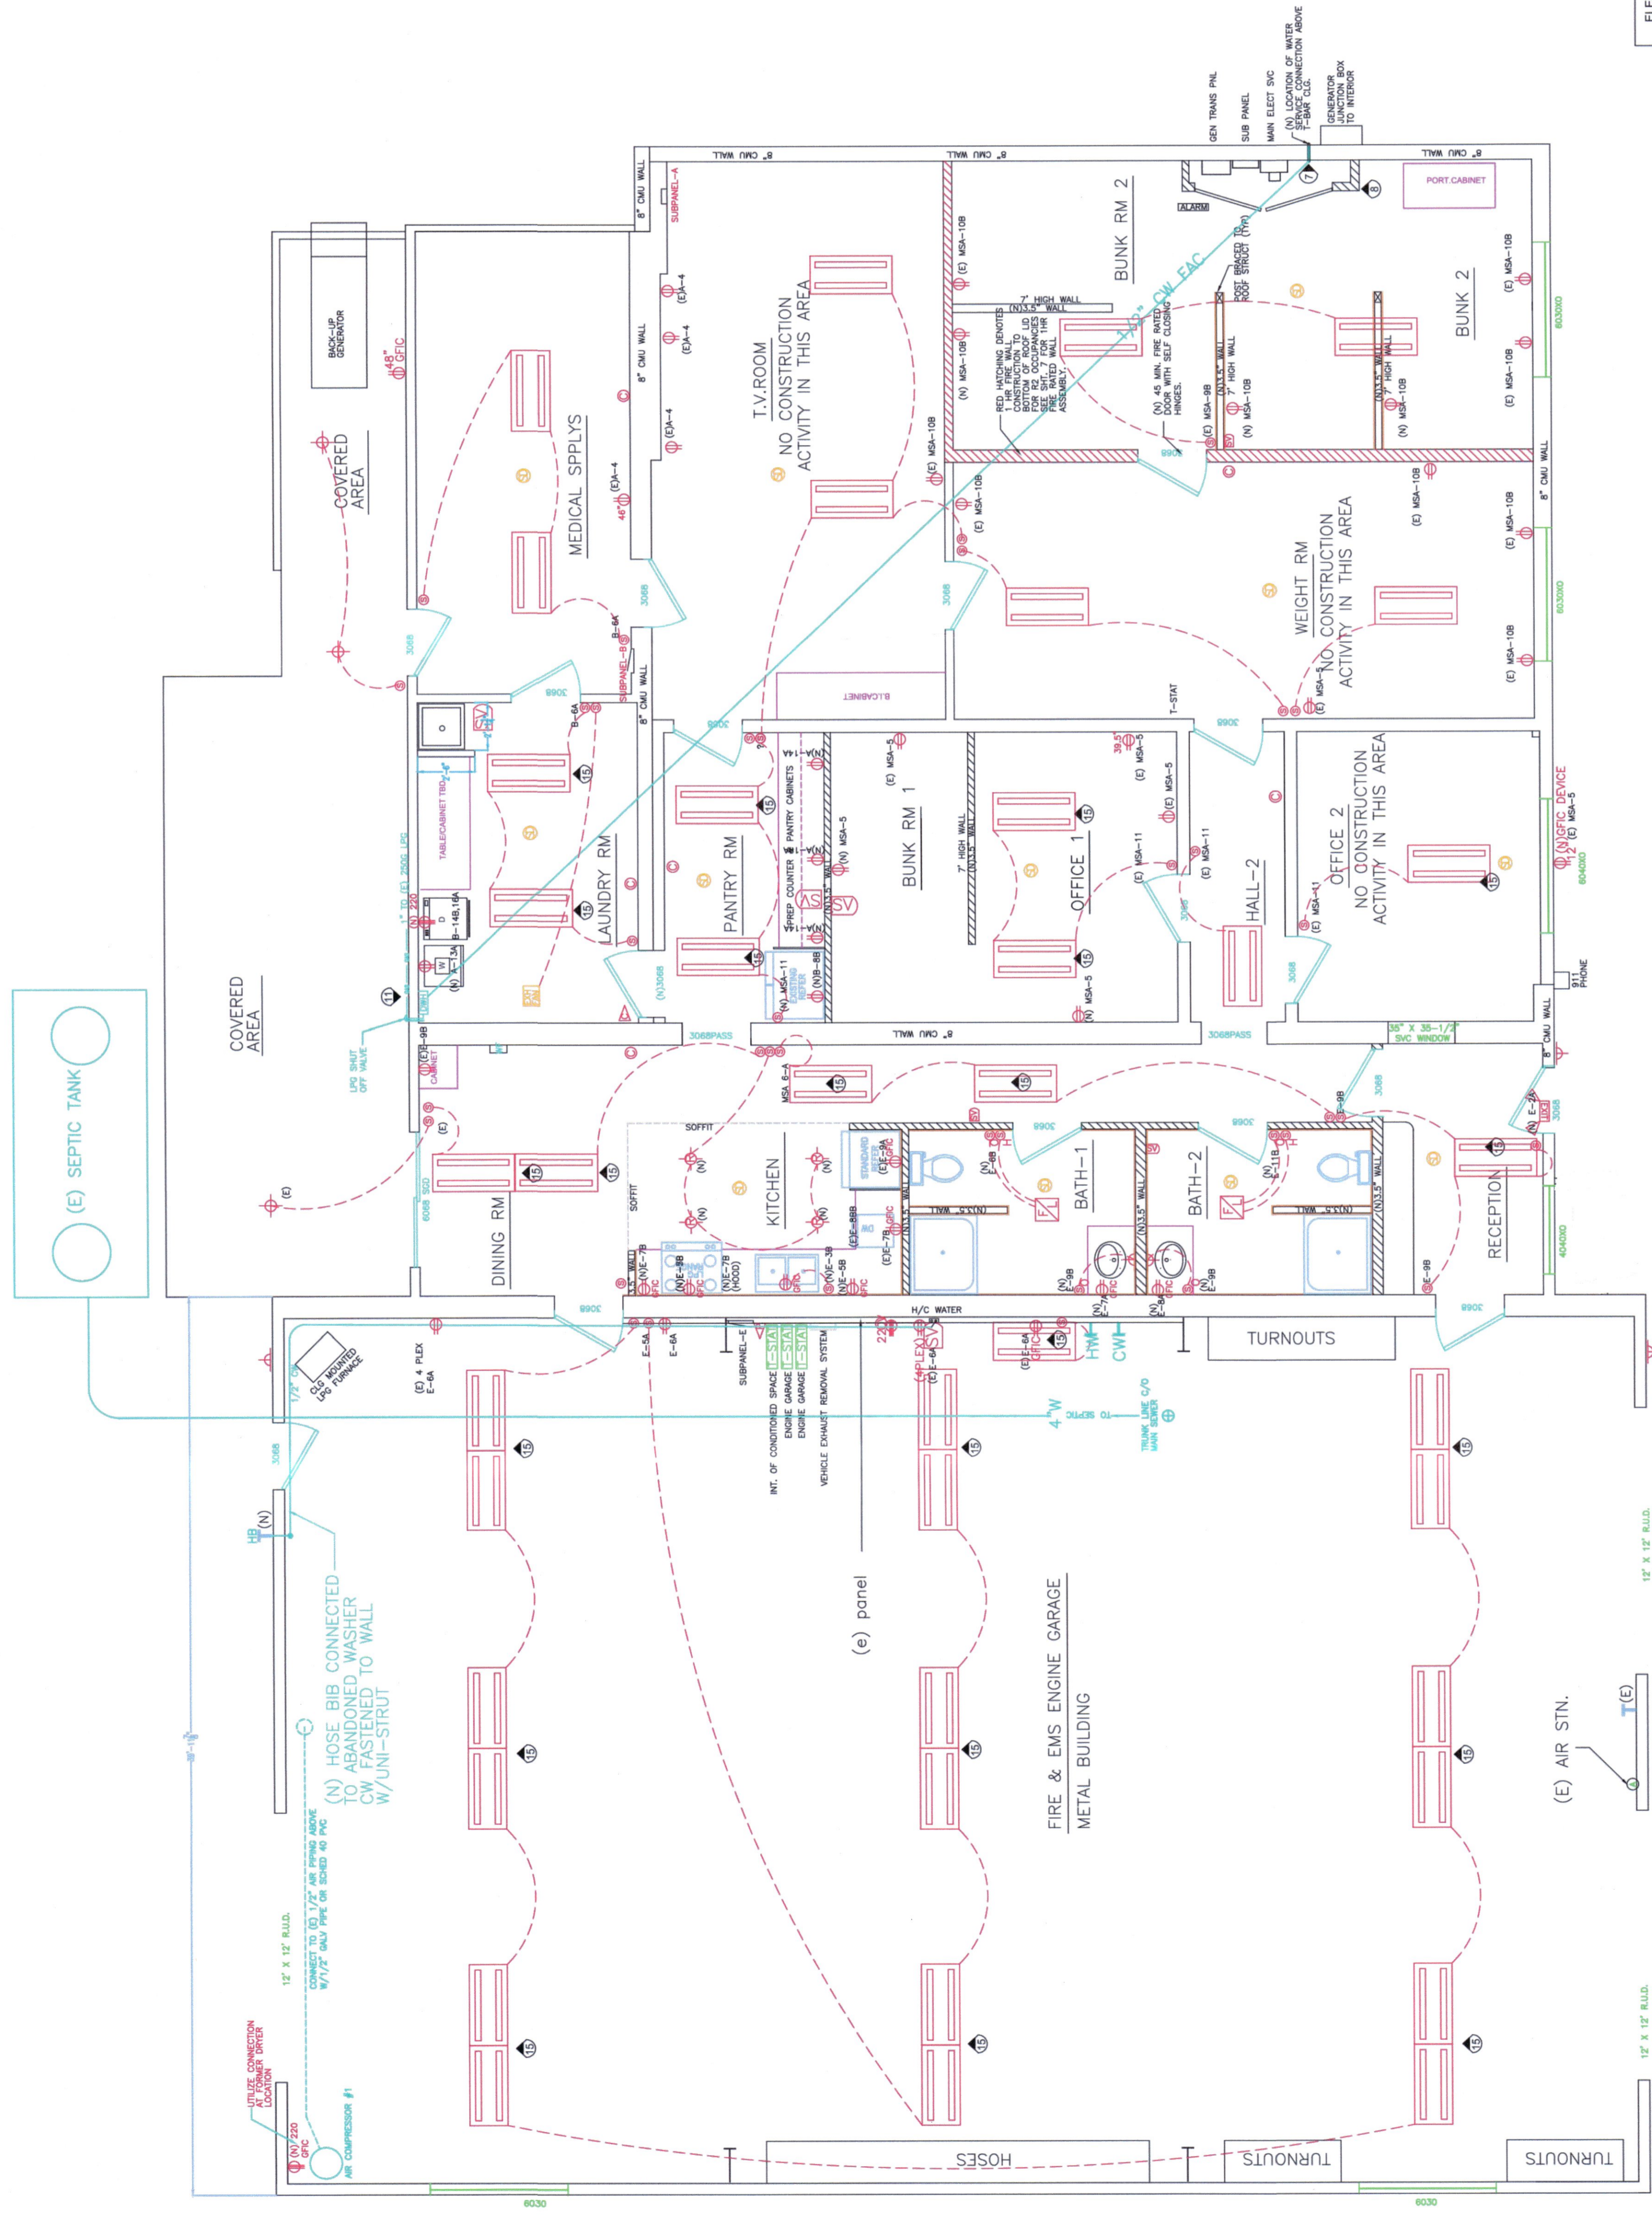

(N) PLUMBING & ELECT PLAN

1/4"

ELECTRICAL / PLUMBING PLAN

1/4" = 1'-0"

1